




SHEET INDEX

SHEET #	SHEET NAME
SCHEMATIC DESIGN SET - GENERAL	
G-01	COVER SHEET
G-02	SITE PLAN - EXISTING CONDITIONS
G-03	CODE ANALYSIS
SCHEMATIC DESIGN SET - CIVIL	
1 OF 2	CONCEPTUAL GRADING PLAN
2 OF 2	FIBER OPTIC EXHIBIT
SCHEMATIC DESIGN SET - ARCHITECTURAL	
A-01	ENLARGED SITE PLAN
A-11	1ST FLOOR PLAN EXISTING
A-12	ROOF PLAN EXISTING
A-13	CEILING PLAN EXISTING
A-14	EXTERIOR ELEVATIONS EXISTING
A-21	FLOOR PLAN - DEMO & IMPROVEMENT
A-22	ROOF PLAN - DEMO & IMPROVEMENT
A-23	CEILING PLAN - DEMO & IMPROVEMENT
A-24	EXTERIOR ELEVATIONS IMPROVEMENT
A-25	EXTERIOR ELEVATIONS IMPROVEMENT
A-26	ENLARGED PLAN -TECH CENTER
SCHEMATIC DESIGN SET - STRUCTURAL	
S-01	FOUNDATION PLAN
S-02	FRAMING PLAN
SCHEMATIC DESIGN SET - MECHANICAL	
M-01	MECHANICAL ABBREVIATIONS AND SYMBOLS LIST
M-02	MECHANICAL SCHEDULES
M-03	MECHANICAL DETAILS
M-10	MECHANICAL DEMOLITION FLOOR PLAN
M-11	MECHANICAL RENOVATION FLOOR PLAN
SCHEMATIC DESIGN SET - PLUMBING	
P-01	PLUMBING ABBREVIATIONS AND SYMBOLS LIST
P-02	PLUMBING SCHEDULES AND DETAILS
P-10	PLUMBING DEMOLITION FLOOR PLAN
P-11	PLUMBING RENOVATION FLOOR PLAN
SCHEMATIC DESIGN SET - ELECTRICAL	
E001	OVERALL SITE PLAN
E002	EXISTING SINGLE-LINE DIAGRAM & PANEL SCHEDULES
E003	SINGLE-LINE DIAGRAM & PANEL SCHEDULE
E101	POWER & LOW VOLTAGE FLOOR PLAN
E101D	EXISTING CONDITION/DEMO POWER & LOW VOLTAGE FLOOR PLAN
E401	REFLECTED CEILING PLAN
E401D	EXISTING CONDITION/DEMO REFLECTED CEILING PLAN

ACCEPTED:			
BY: _____		DATE: _____	
RENE GUERRERO, PUBLIC WORKS DIRECTOR			
RECOMMENDED:			
BY: _____		DATE: _____	
ARNOLD DICHOSA, P.E., RCE NO. 86038, CITY ENGINEER			
CITY OF POMONA			
PUBLIC WORKS DEPARTMENT/ENGINEERING DIVISION			
LA CASITA TEEN CENTER - TECH STUDIO RENOVATION			
455 E. ARROW HIGHWAY POMONA, CA			
SCALE:	DESIGNED: DRAWN: CHECKED: REVIEWED:	PVT. ENG. PVT. ENG.	SHEET: G-01 COVER SHEET

100% SCHEMATIC DESIGN	10/8/2025	JJS
△	REVISION:	DATE INITIAL

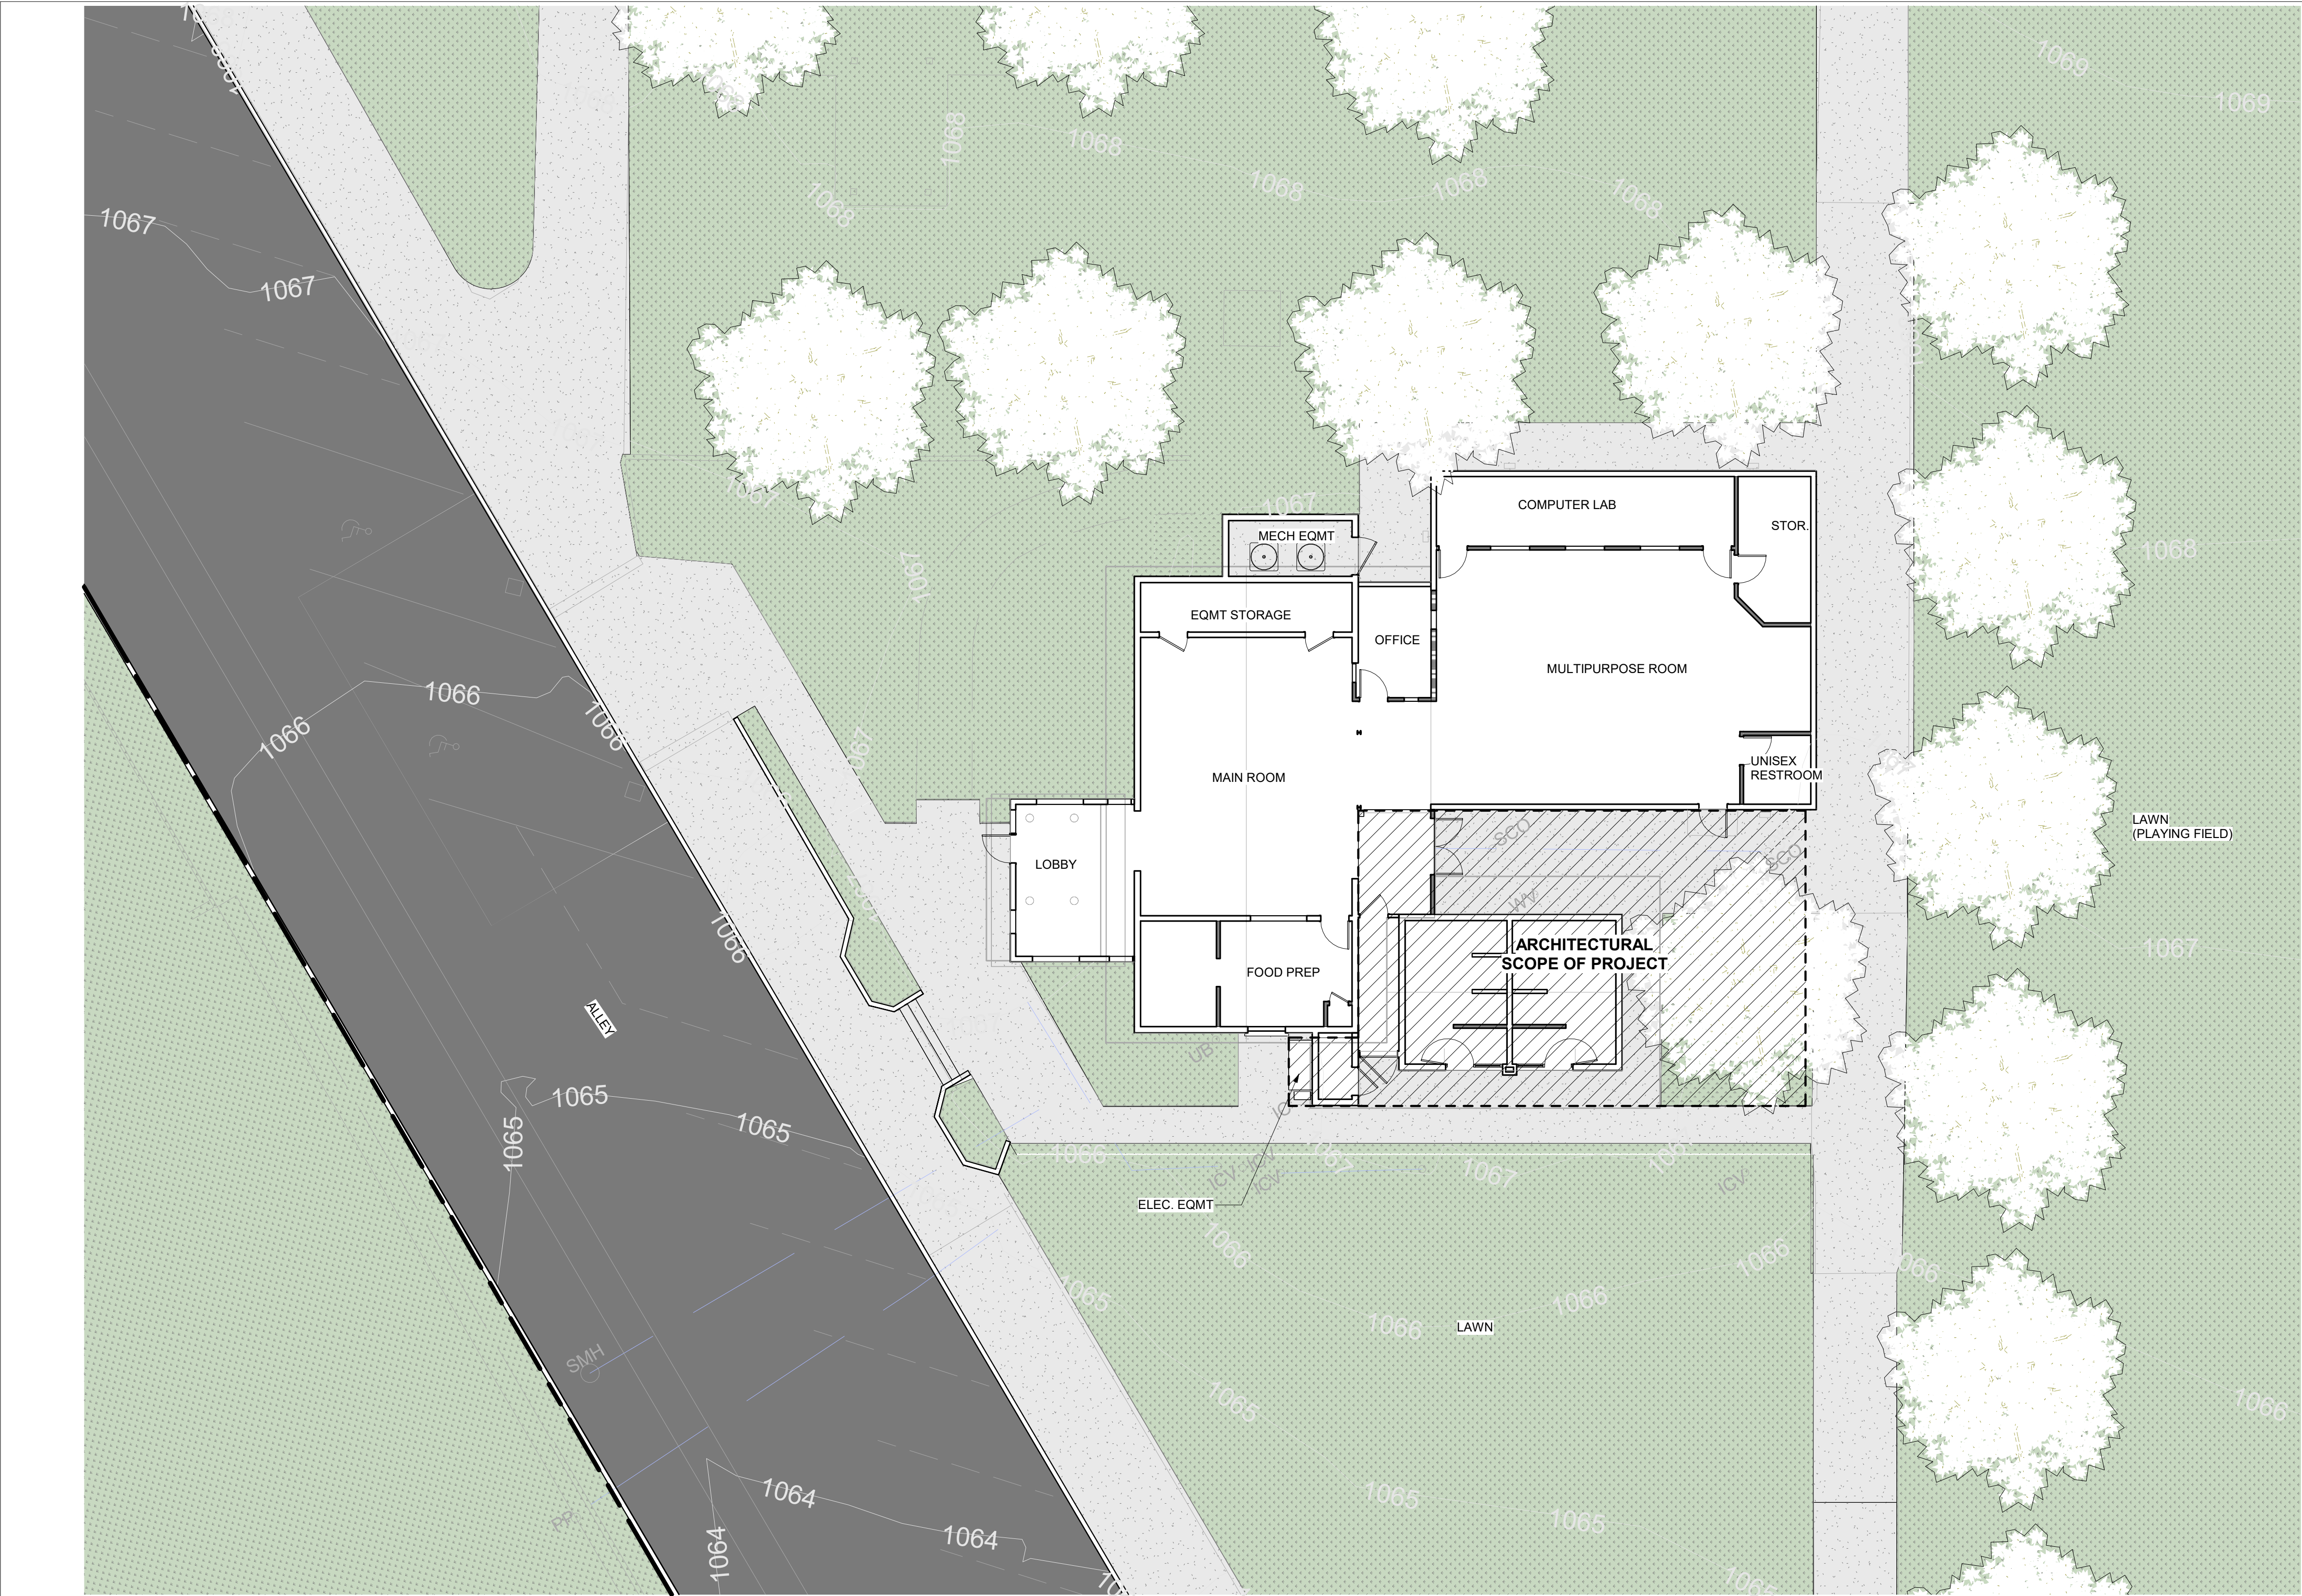

ARCHITECTURAL SITE PLAN - EXISTING

1
1" = 10'-0"



VACINITY MAP

2
1" = 400'-0"

LEGEND

- BUILDING
- LANDSCAPE
- CONCRETE WALKING SURFACE
- ASPHALT DRIVE AISLE
- SCOPE OF WORK
- PROPERTY LINE



100% SCHEMATIC DESIGN	10/8/2025	JJS
REVISION:	DATE	INTIAL

ACCEPTED:

BY: _____ DATE: _____
RENE GUERRERO, PUBLIC WORKS DIRECTOR

RECOMMENDED:

BY: _____ DATE: _____
ARNOLD DICHOSA, P.E., RCE NO. 86038, CITY ENGINEER

CITY OF POMONA

PUBLIC WORKS DEPARTMENT/ENGINEERING DIVISION

LA CASITA TEEN CENTER - TECH STUDIO RENOVATION


455 E. ARROW HIGHWAY
POMONA, CA

SCALE:

DESIGNED: _____
DRAWN: _____
CHECKED: _____
REVIEWED: _____

PVT. ENG. _____
PVT. ENG. _____
...

SHEET: **G-02**
SITE PLAN -
EXISTING
CONDITIONS

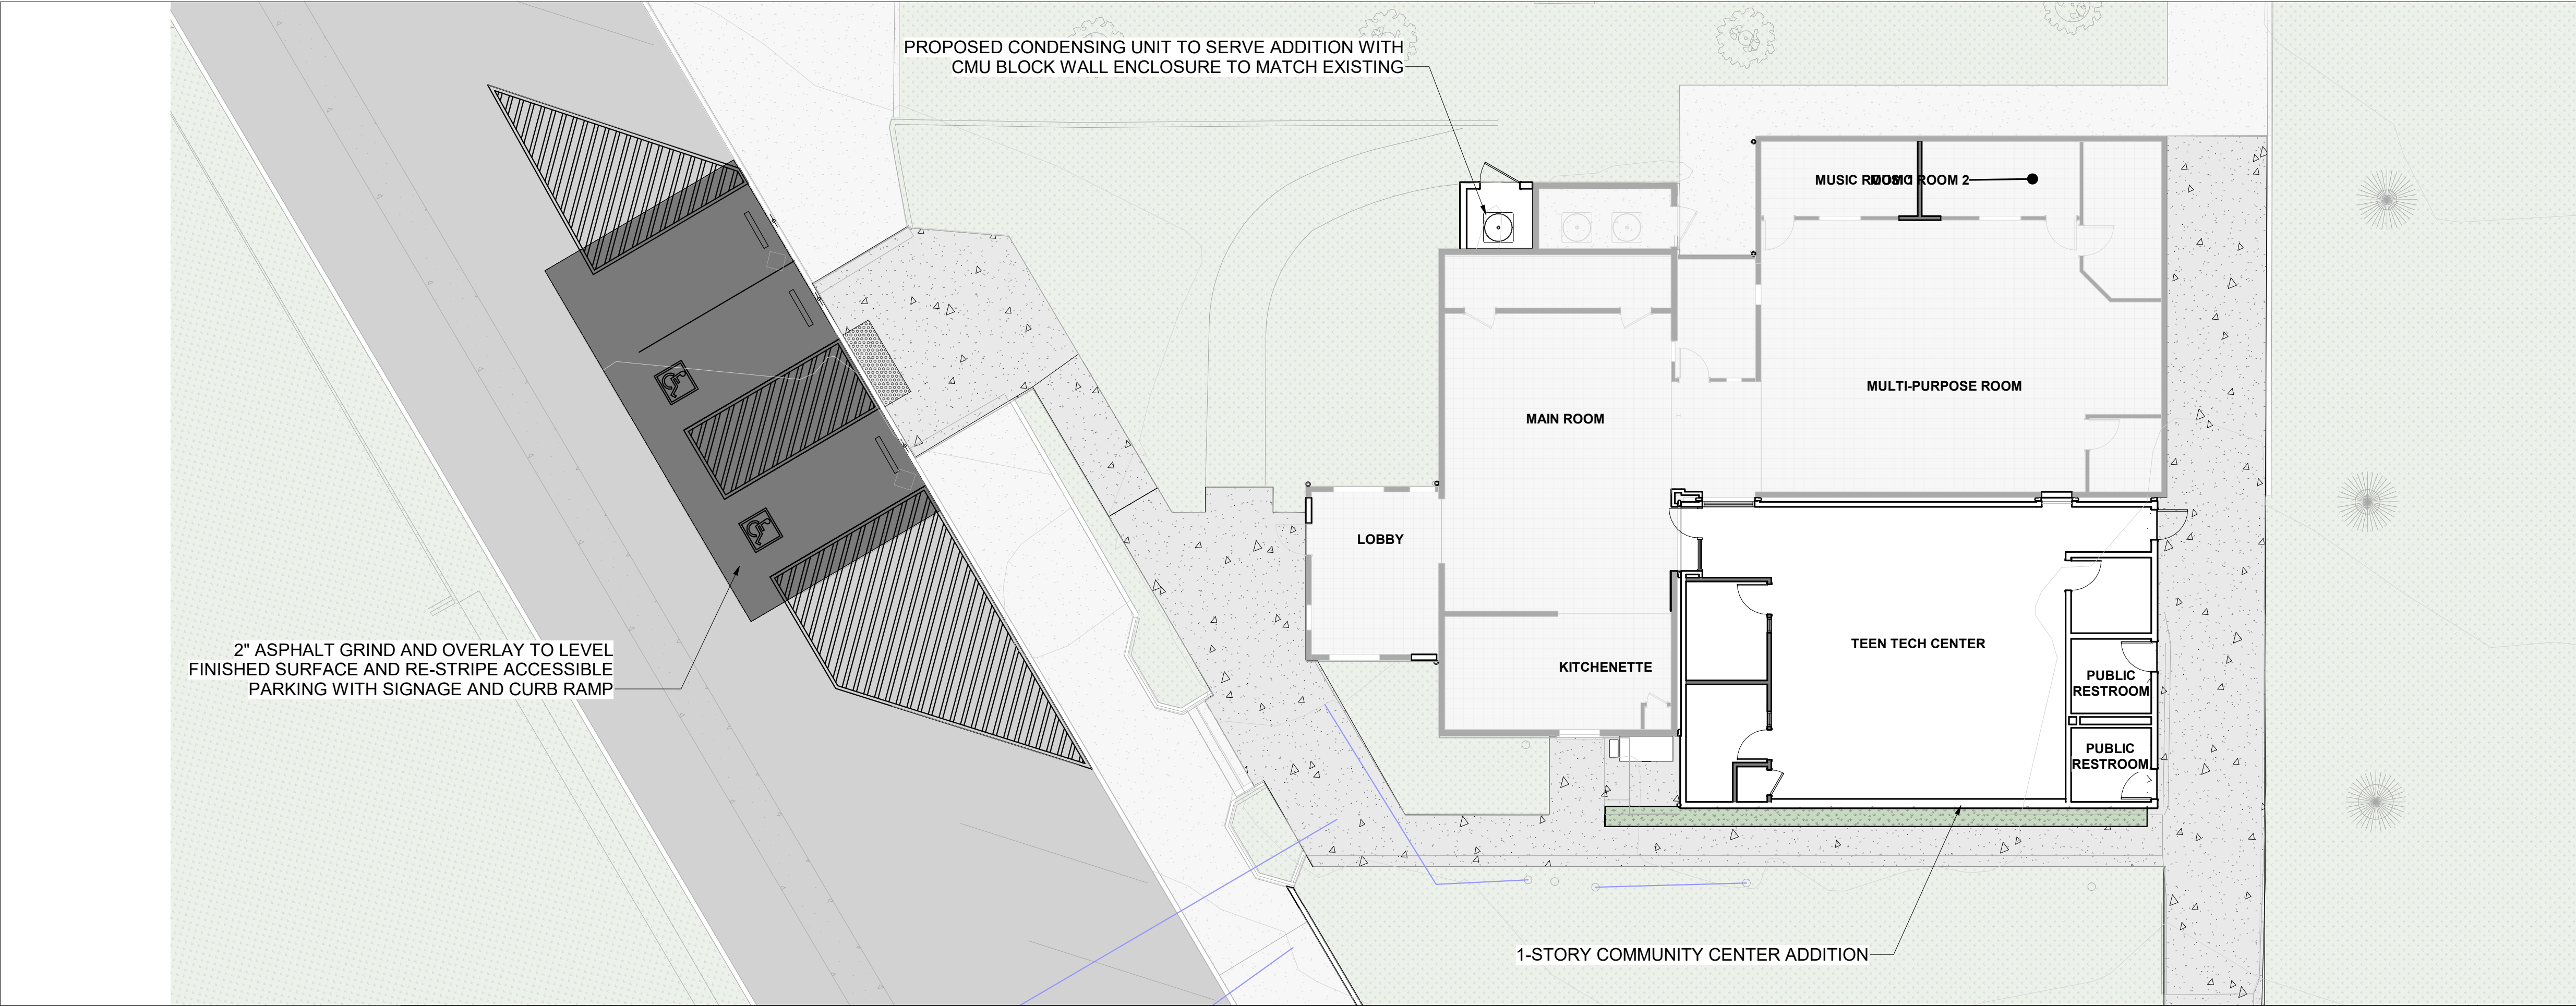

LEGEND - IMPROVEMENT

BUILDING ADDITION

PROPOSED PLANTER LANDSCAPE

PROPOSED CONCRETE WALKING SURFACE

PROPOSED GRIND & OVERLAY ASPHALT


EXISTING PLANTER LANDSCAPE

EXISTING CONCRETE WALKING SURFACE

EXISTING GRIND & OVERLAY ASPHALT

SITE PLAN - IMPROVEMENT

2
1" = 10'-0"

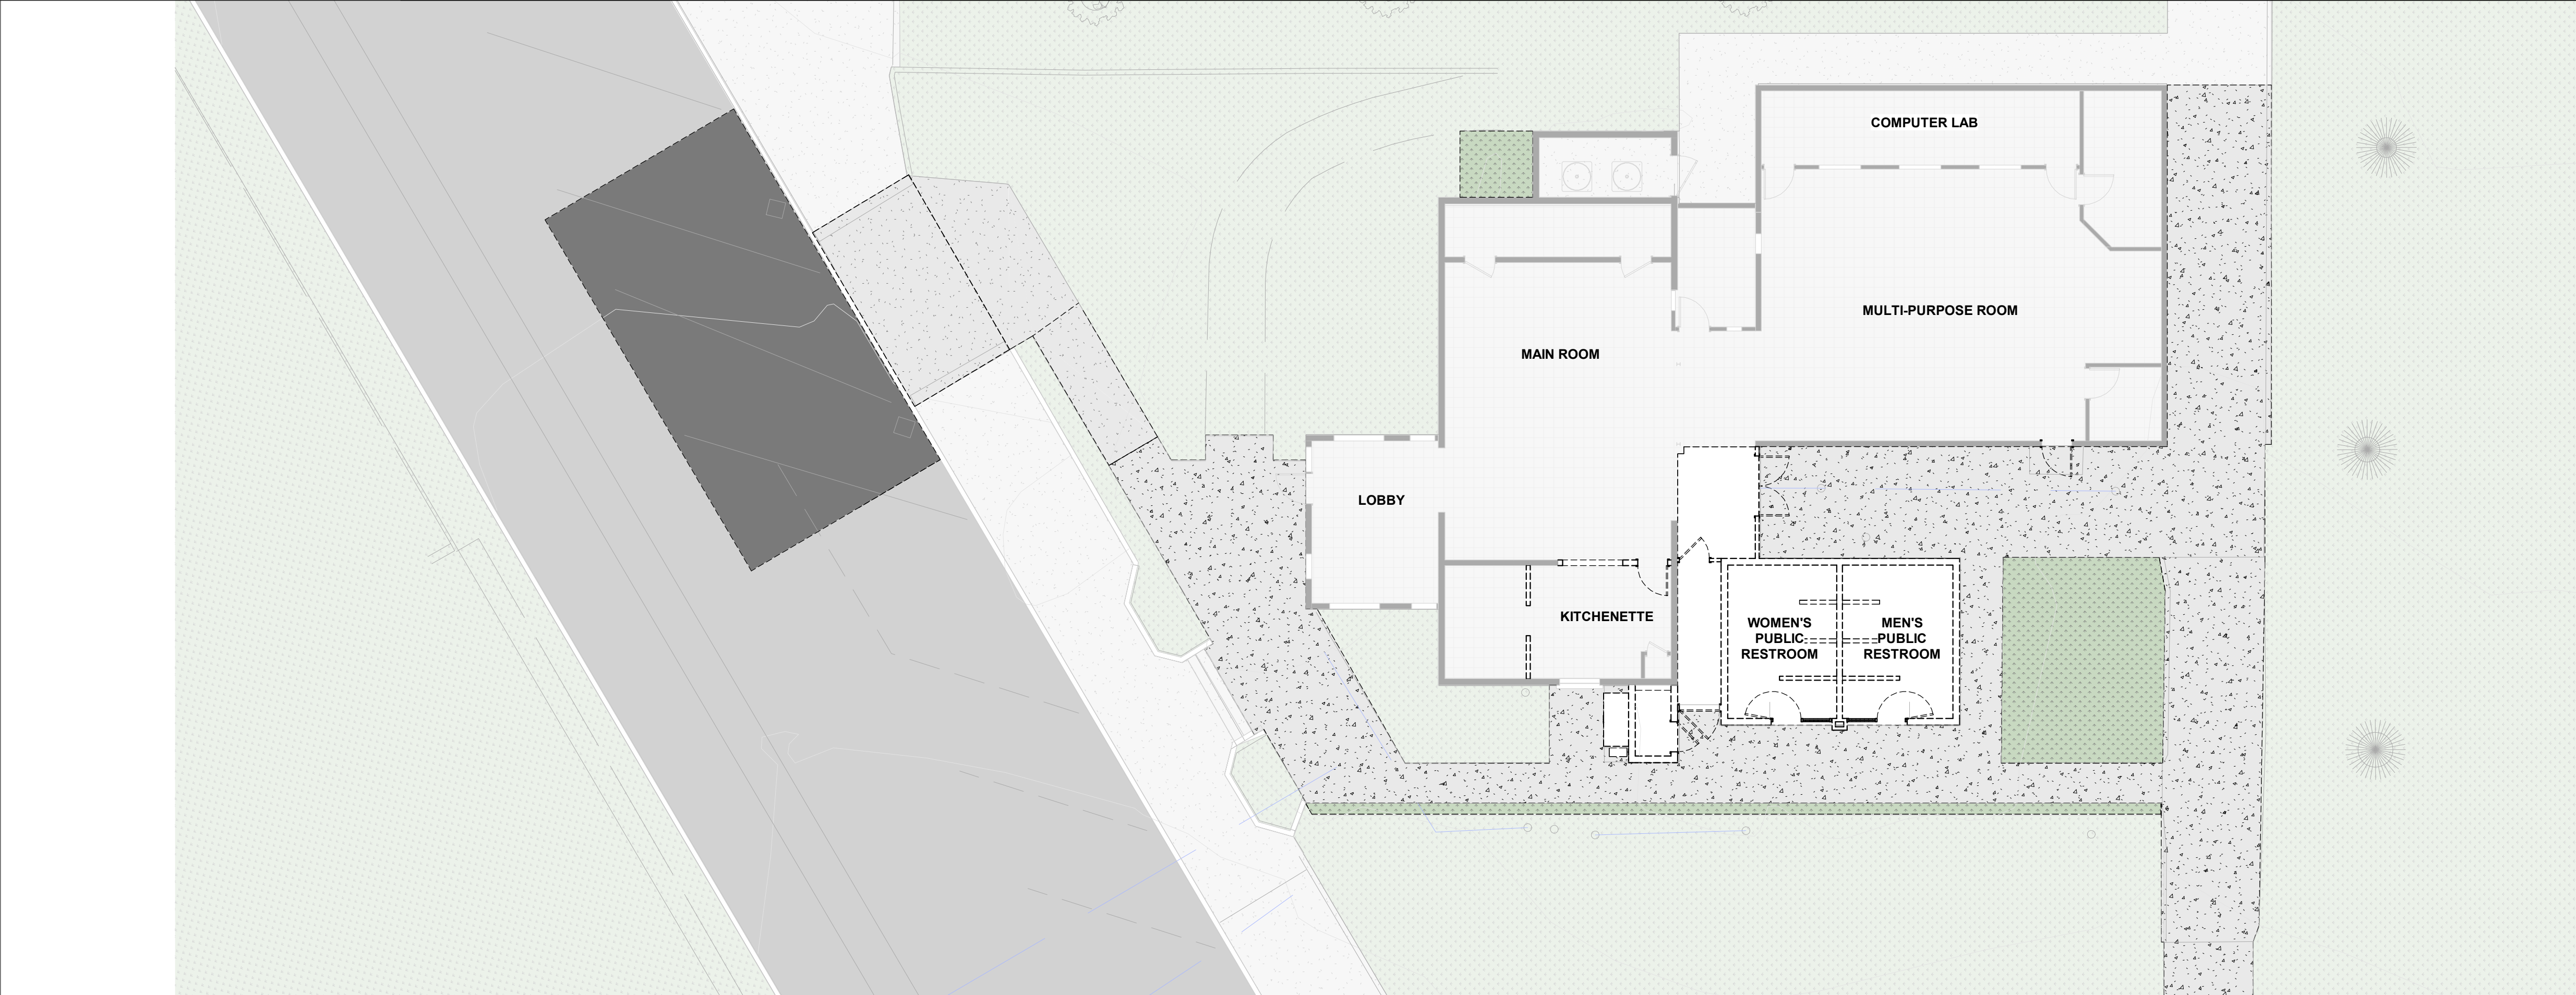

LEGEND - DEMOLITION

BUILDING DEMOLITION

DEMOLISH LANDSCAPE

DEMOLISH CONCRETE WALKING SURFACE

2" ASPHALT GRIND

EXISTING LANDSCAPE

EXISTING CONCRETE WALKING SURFACE

EXISTING ASPHALT DRIVE AISLE

SITE PLAN - DEMOLITION

1
1" = 10'-0"

100% SCHEMATIC DESIGN	10/8/2025	JJS
REVISION:	DATE	INITIAL

ACCEPTED:

BY: _____ DATE: _____
RENE GUERRERO, PUBLIC WORKS DIRECTOR

RECOMMENDED:

BY: _____ DATE: _____
ARNOLD DICHOSA, P.E., RCE NO. 86038, CITY ENGINEER

CITY OF POMONA

PUBLIC WORKS DEPARTMENT/ENGINEERING DIVISION

LA CASITA TEEN CENTER - TECH STUDIO RENOVATION

 
455 E. ARROW HIGHWAY
POMONA, CA

SCALE:

DRAWN: _____
CHECKED: _____
REVIEWED: _____


PVT. ENG. _____
PVT. ENG. _____
...

SHEET:
A-01
ENLARGED
SITE PLAN




WEST ELEVATION - EXISTING

 1


$$3/16'' = 1'-0''$$

 
SOUTH ELEVATION - EXISTING

2
$$3/16'' = 1'-0''$$

 
 
EAST ELEVATION - EXISTING

3

$$3/16'' = 1'-0''$$


NORTH ELEVATION - EXISTING

4

$$3/16'' = 1'-0''$$


SECTION 1 - EXISTING

5

$$3/16'' = 1'-0''$$

ACCEPTED:

BY: _____ DATE: _____
RENE GUERRERO, PUBLIC WORKS DIRECTOR

RENE GUERRERO, PUBLIC WORKS DIRECTOR

RECOMMENDED:

BY: _____ DATE: _____
ARNOLD DICHOSA, P.E., RCE NO. 86038, CITY ENGINEER

ARNOLD DICHOSA, P.E., RCE NO. 86038, CITY ENGINEER

CITY OF POMONA

PUBLIC WORKS DEPARTMENT/ENGINEERING DIVISION

LA CASITA TEEN CENTER - TECH STUDIO RENOVATION

455 E. ARROW HIGHWAY
POMONA, CA

POMONA, CA

SCALE:

DESIGNED:

DESIGNED:
DRAWN:

CHECKED:

REVIEWED:

PVT ENG

PVT. ENG.

SHEET:

A-14

A-14
EXTERIO

EXISTING


	EXISTING
--	----------

FH 624 A




SOUTH ELEVATION - IMPROVEMENT

1
3/16" = 1'-0"

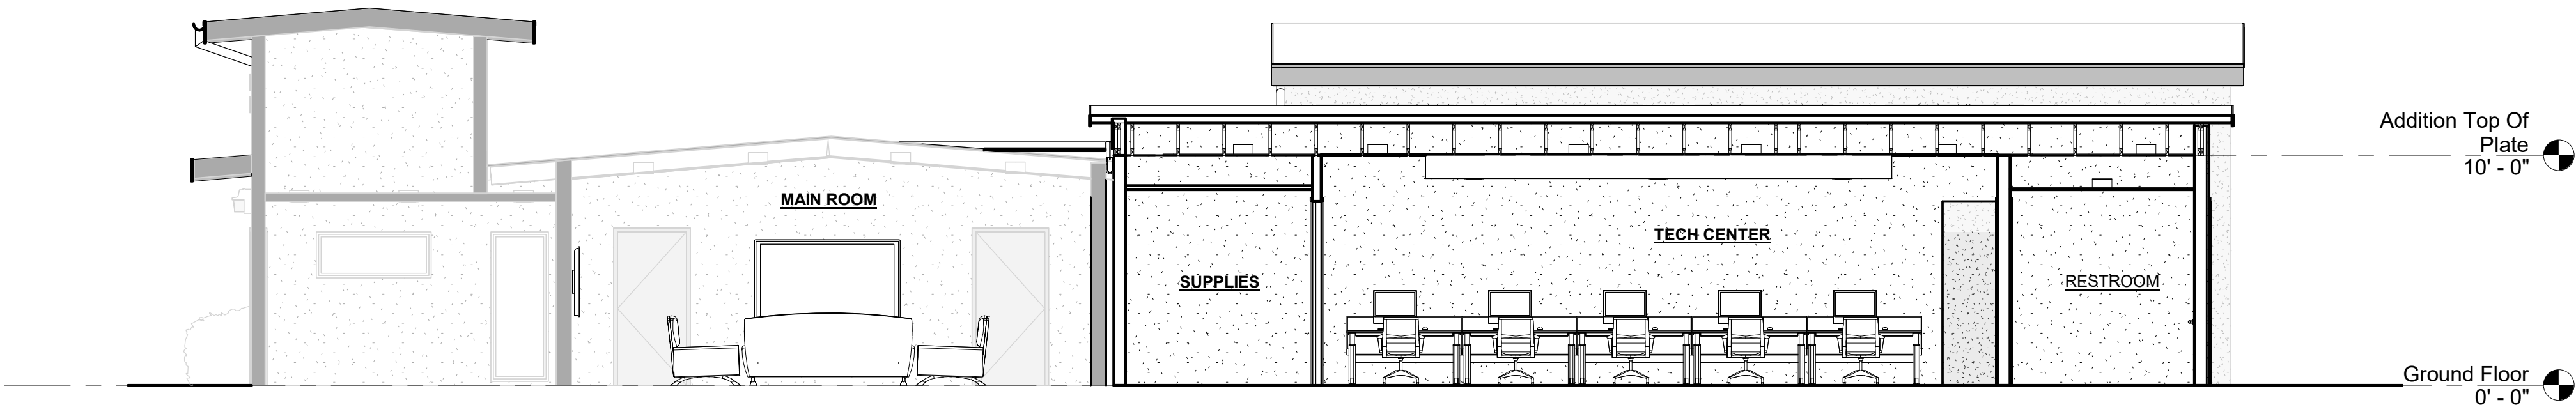


SECTION A - IMPROVEMENT

1A
3/16" = 1'-0"

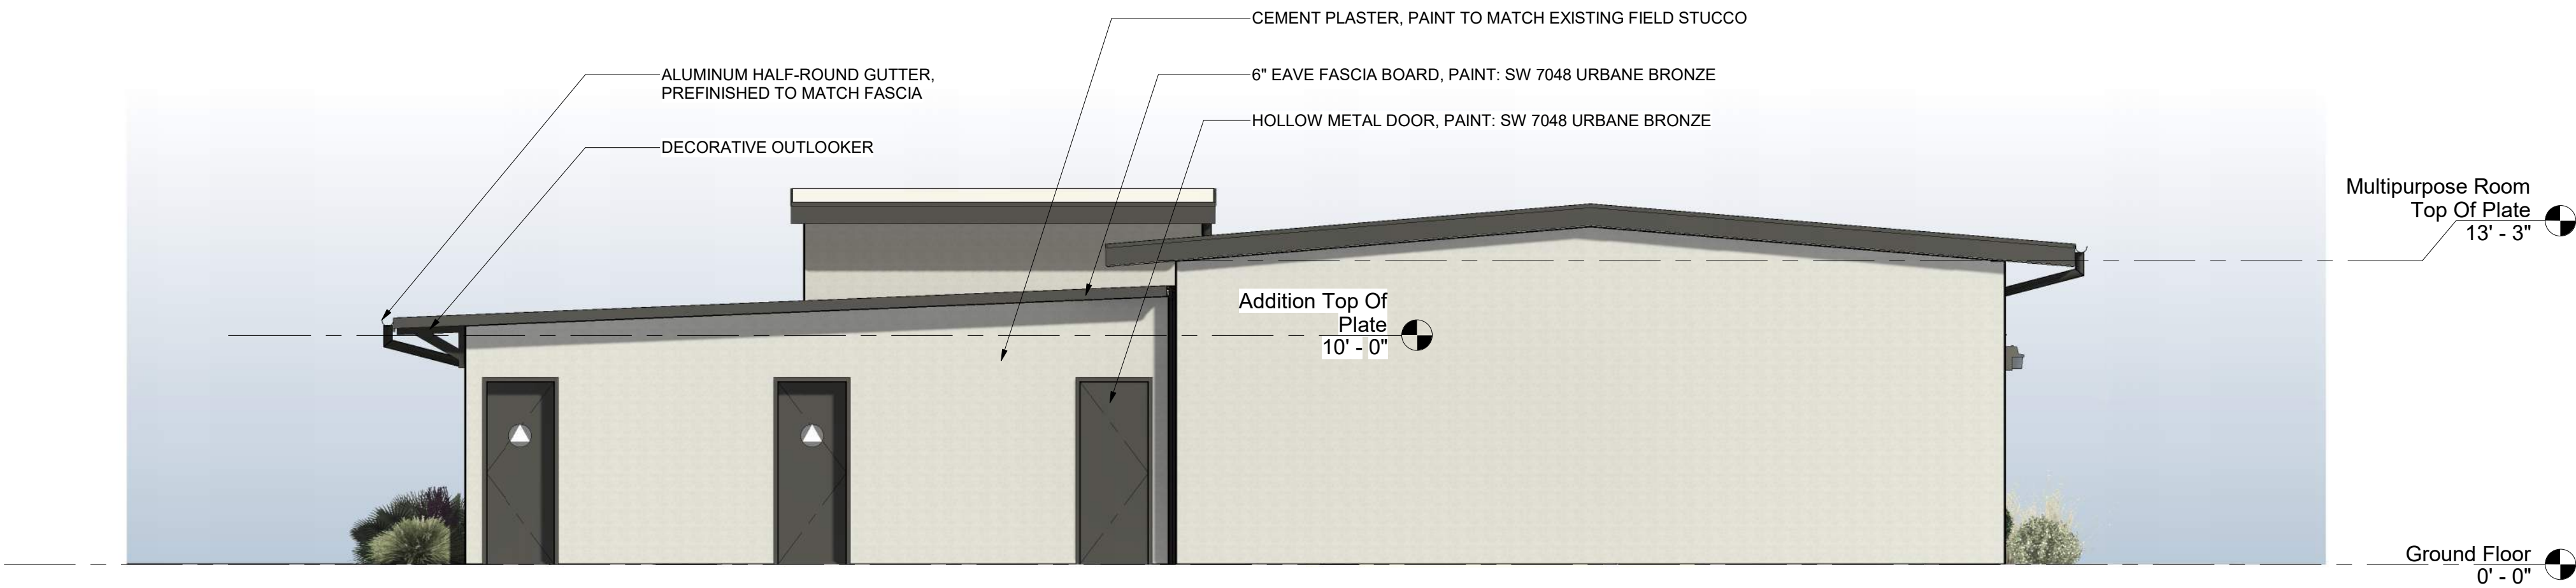

EAST ELEVATION - IMPROVEMENT

2
3/16" = 1'-0"

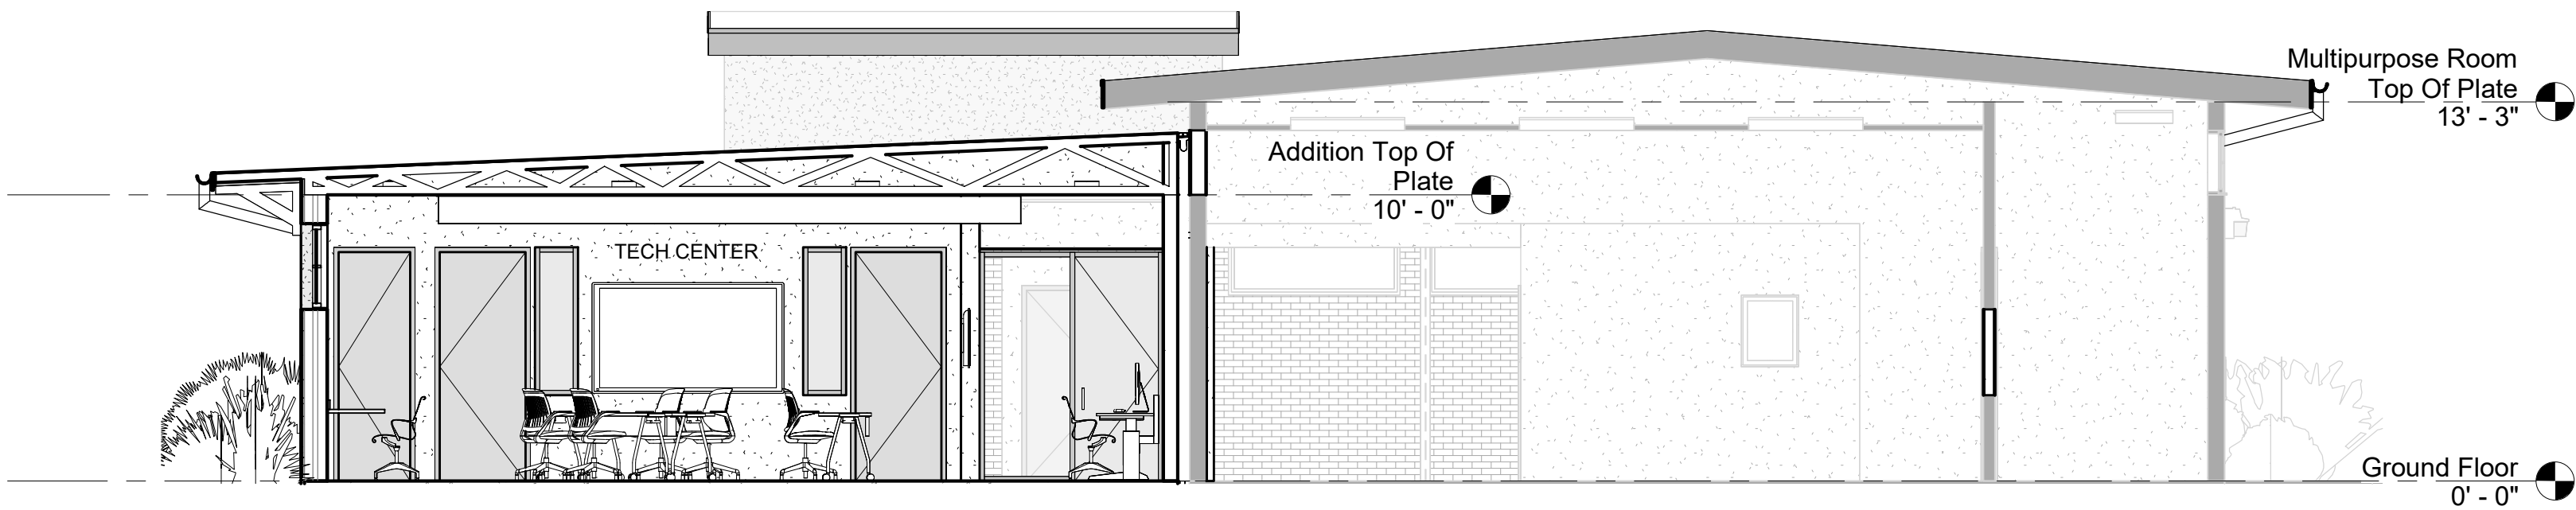

SECTION B - IMPROVEMENT

2A
3/16" = 1'-0"

100% SCHEMATIC DESIGN	10/8/2025	JJS
REVISION:	DATE	INITIAL

ACCEPTED:			
BY: _____		DATE: _____	
RENE GUERRERO, PUBLIC WORKS DIRECTOR			
RECOMMENDED:			
BY: _____		DATE: _____	
ARNOLD DICHOSA, P.E., RCE NO. 86038, CITY ENGINEER			
CITY OF POMONA			
PUBLIC WORKS DEPARTMENT/ENGINEERING DIVISION			
LA CASITA TEEN CENTER - TECH STUDIO RENOVATION			
455 E. ARROW HIGHWAY POMONA, CA			
SCALE:	DESIGNED: DRAWN: CHECKED: REVIEWED:	PVT. ENG. PVT. ENG.	SHEET: A-24 EXTERIOR ELEVATIONS IMPROVEMENT





VIEW FROM SOUTH-WEST CORNER



VIEW FROM SOUTH-EAST CORNER

100% SCHEMATIC DESIGN	10/8/2025	JJS
REVISION:	DATE	INITIAL

ACCEPTED:			
BY: _____		DATE: _____	
RECOMMENDED:			
BY: _____		DATE: _____	
CITY OF POMONA			
PUBLIC WORKS DEPARTMENT/ENGINEERING DIVISION			
LA CASITA TEEN CENTER - TECH STUDIO RENOVATION			
455 E. ARROW HIGHWAY POMONA, CA			
SCALE:	DESIGNED: DRAWN: CHECKED: REVIEWED:	PVT. ENG. PVT. ENG.	SHEET: A-25 EXTERIOR ELEVATIONS IMPROVEMENT

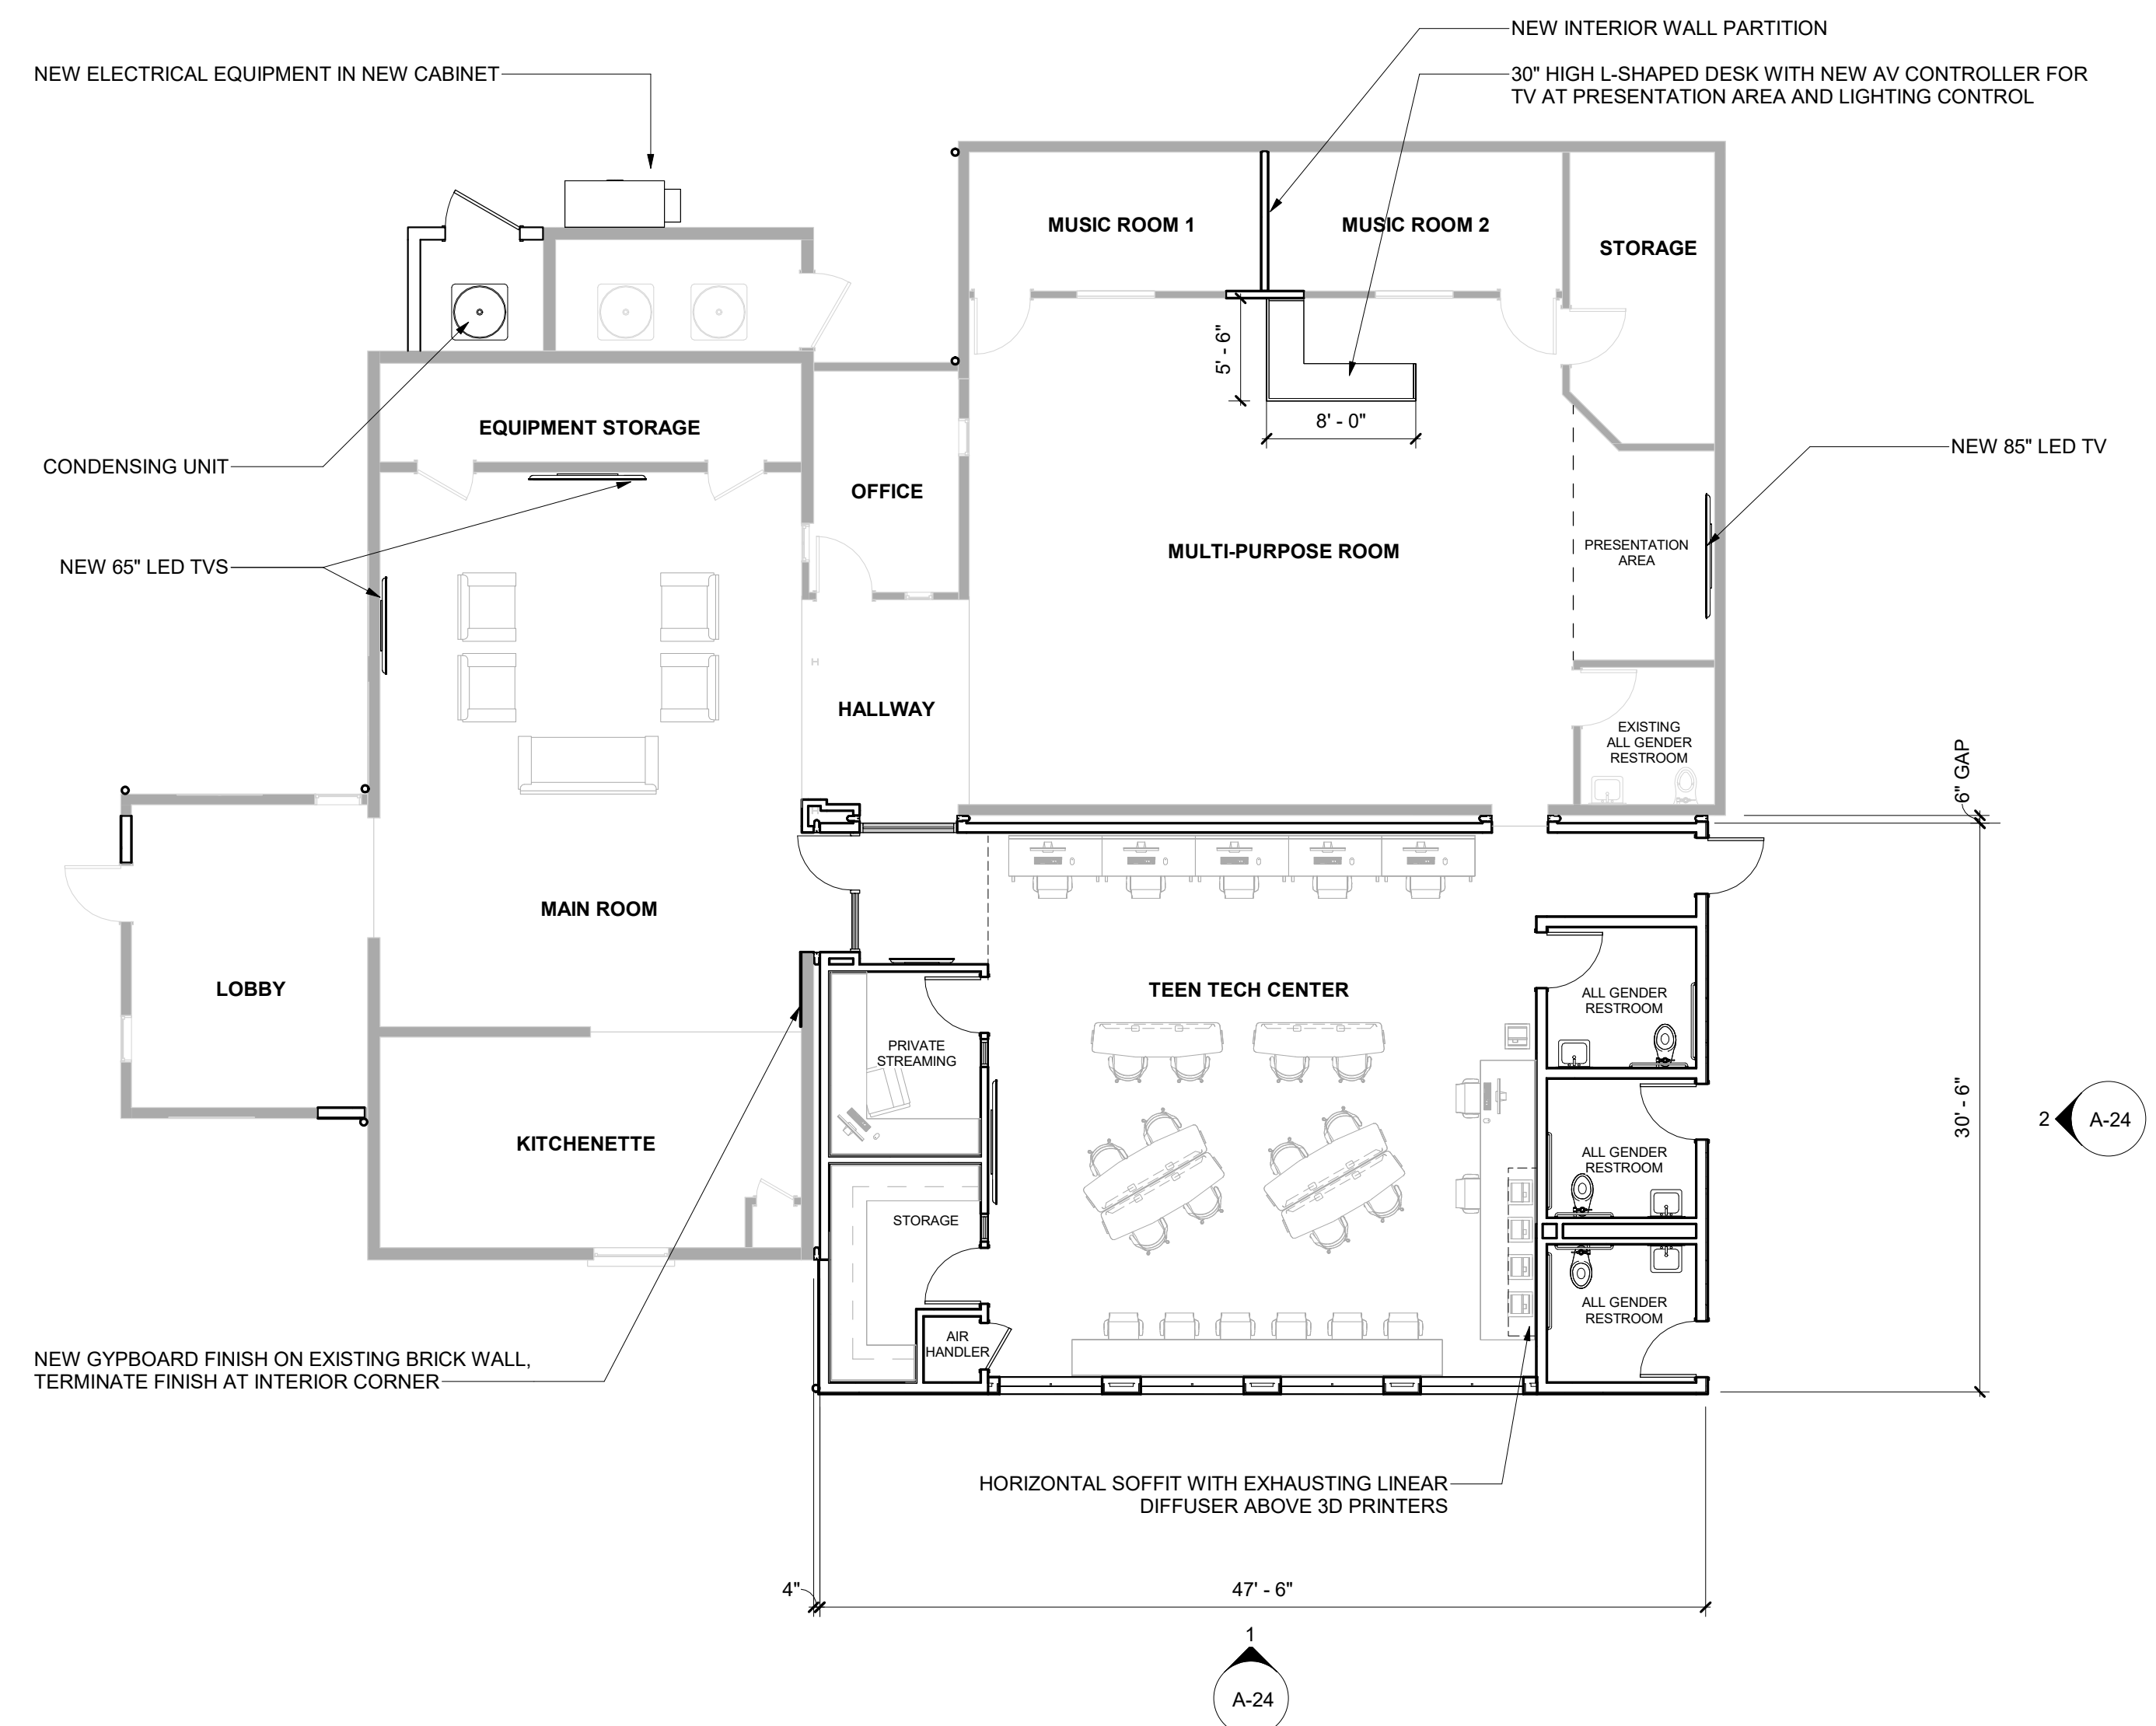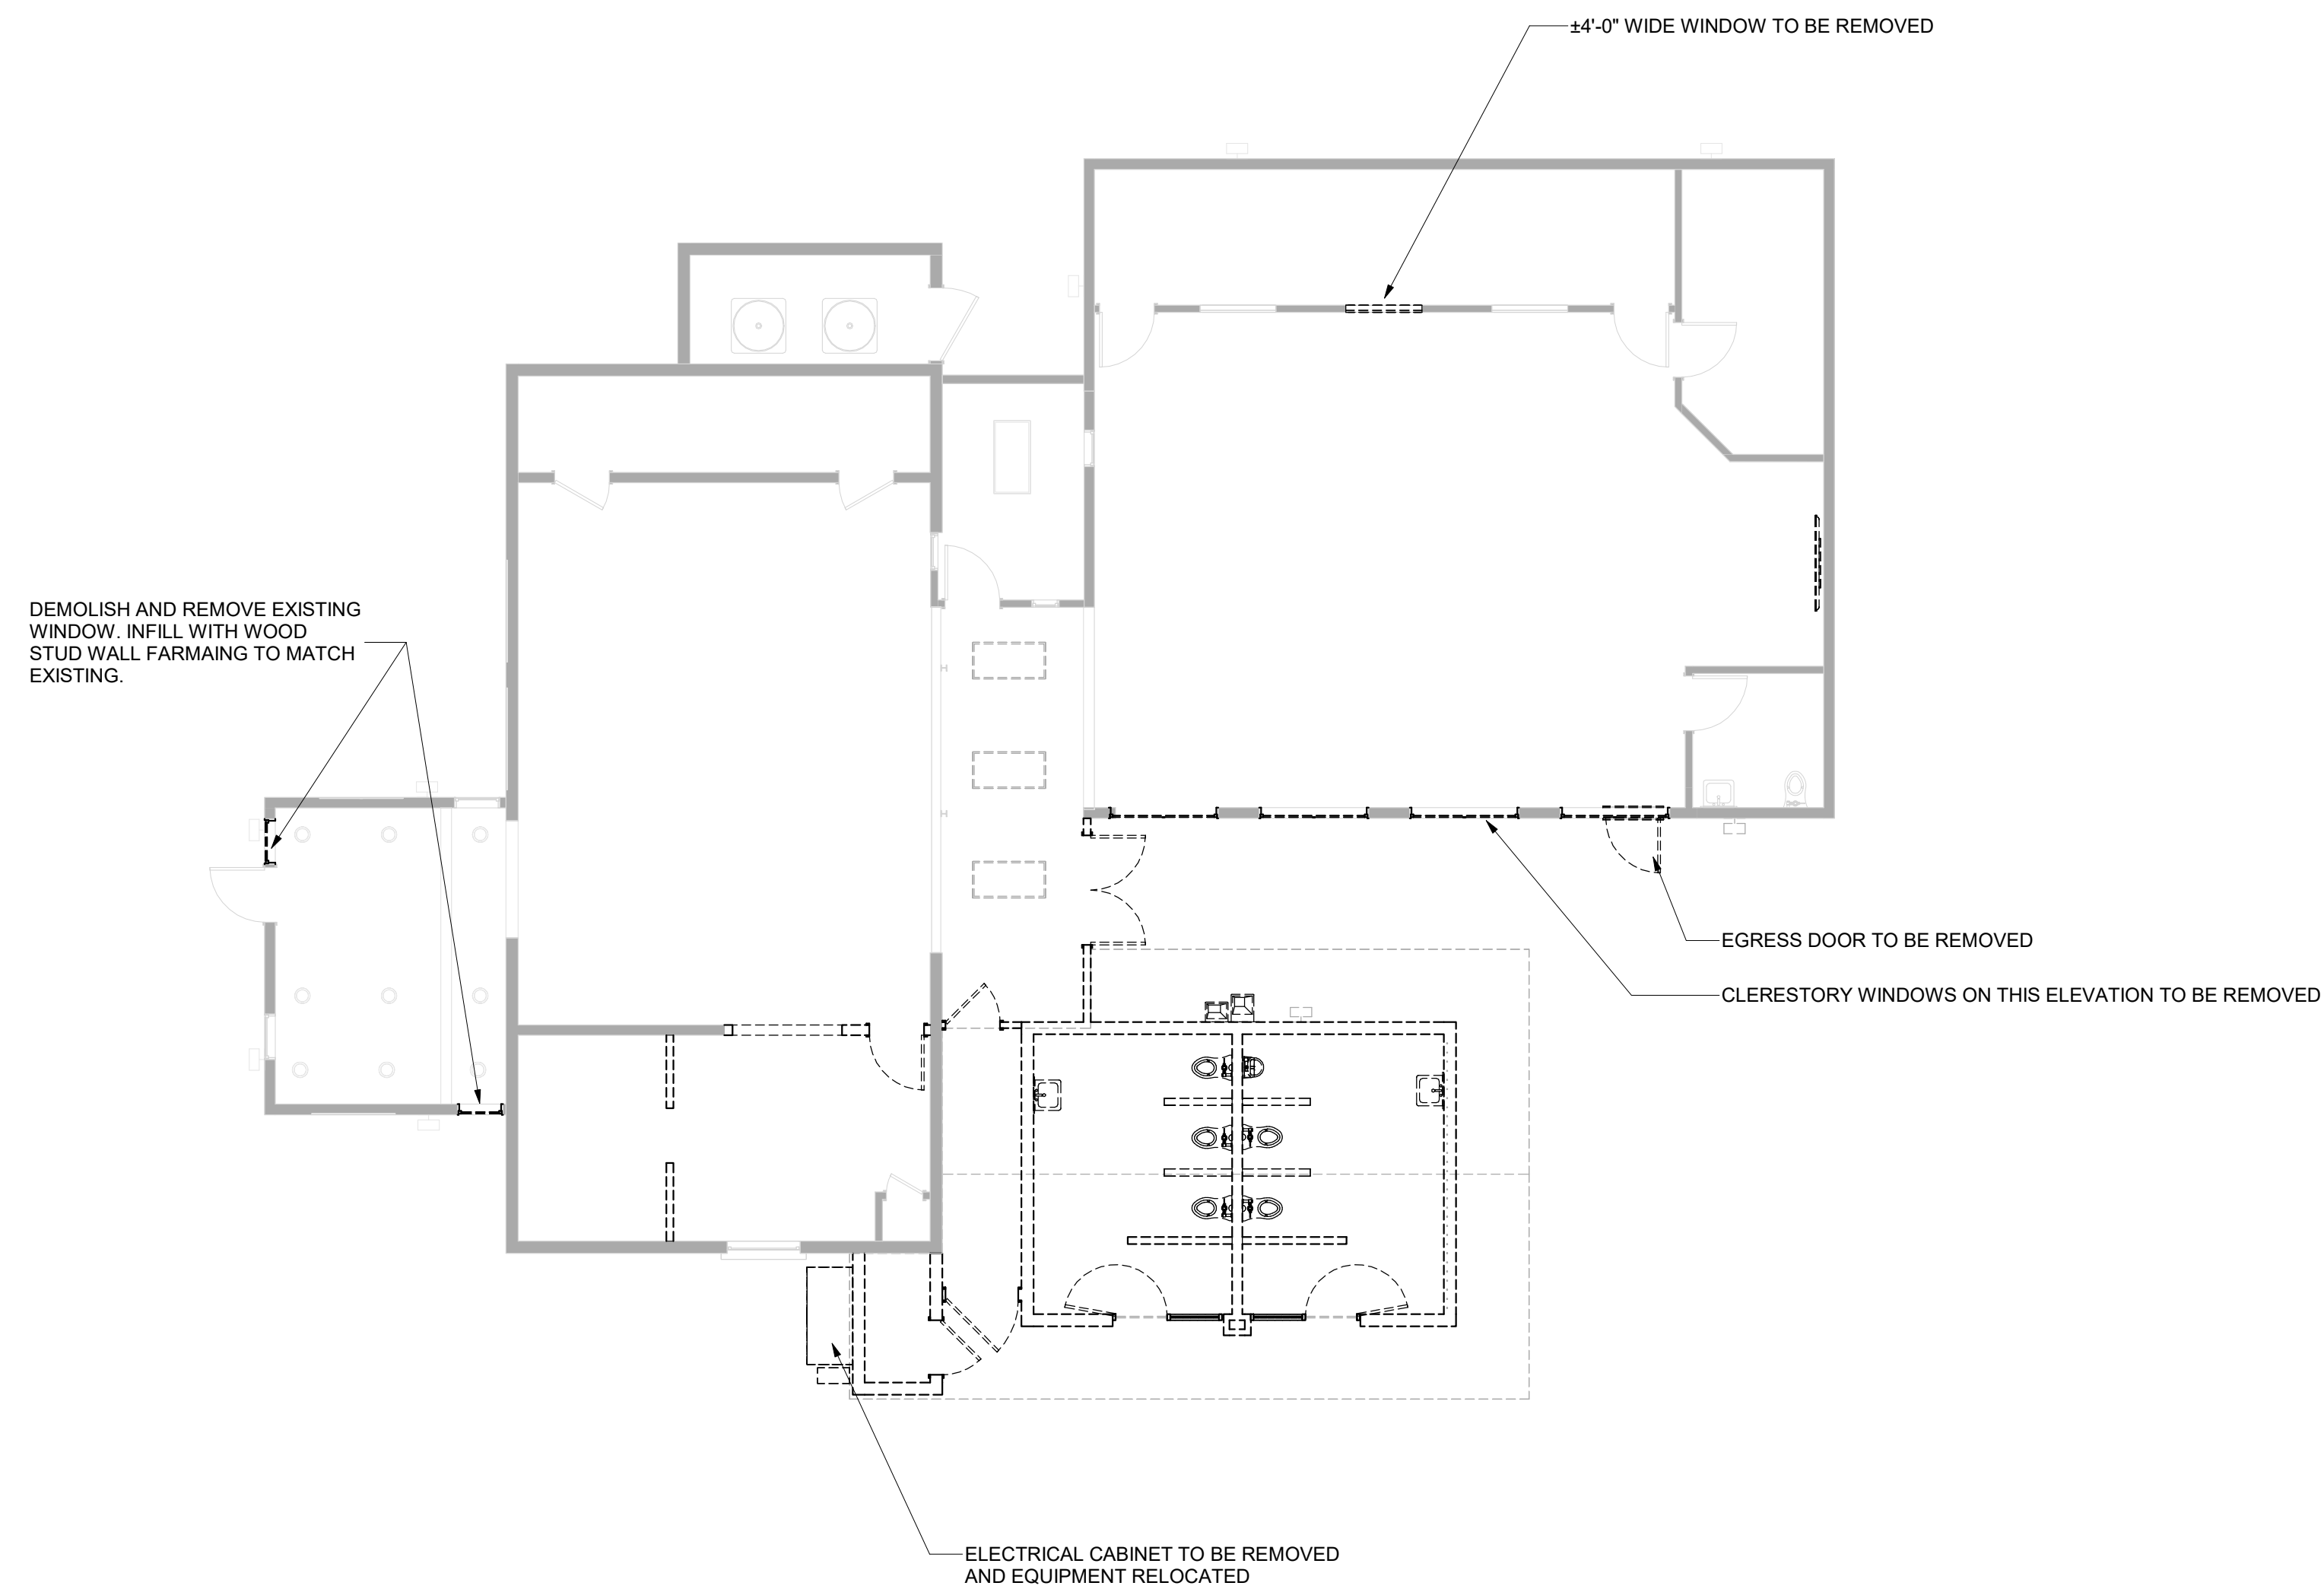

FLOOR PLAN - DEMOLITION

2

1/8" = 1'-0"

FLOOR PLAN - IMPROVEMENT

1

1/8" = 1'-0"

LEGEND

(E) WALL TO REMAIN

WOOD STUD WALL

MILLWORK, SEE MILLWORK DETAILS

WD WESTGROUP
DESIGNS

architecture | planning | interior design | branding

	100% SCHEMATIC DESIGN	10/8/2025	JJS
△	REVISION:	DATE	INITIAL

ACCEPTED:

BY: _____ DATE: _____
RENE GUERRERO, PUBLIC WORKS DIRECTOR

RECOMMENDED:

BY: _____ DATE: _____
ARNOLD DICHOSA, P.E., RCE NO. 86038, CITY ENGINEER


CITY OF POMONA

PUBLIC WORKS DEPARTMENT/ENGINEERING DIVISION

LA CASITA TEEN CENTER - TECH STUDIO RENOVATION

455 E. ARROW HIGHWAY
POMONA, CA


SCALE:	DESIGNED:	PVT. ENG. _____	SHEET: A-21 FLOOR PLAN - DEMO & IMPROVEMENT
	DRAWN:	PVT. ENG. _____	
	CHECKED:	_____	
	REVIEWED:	... _____	

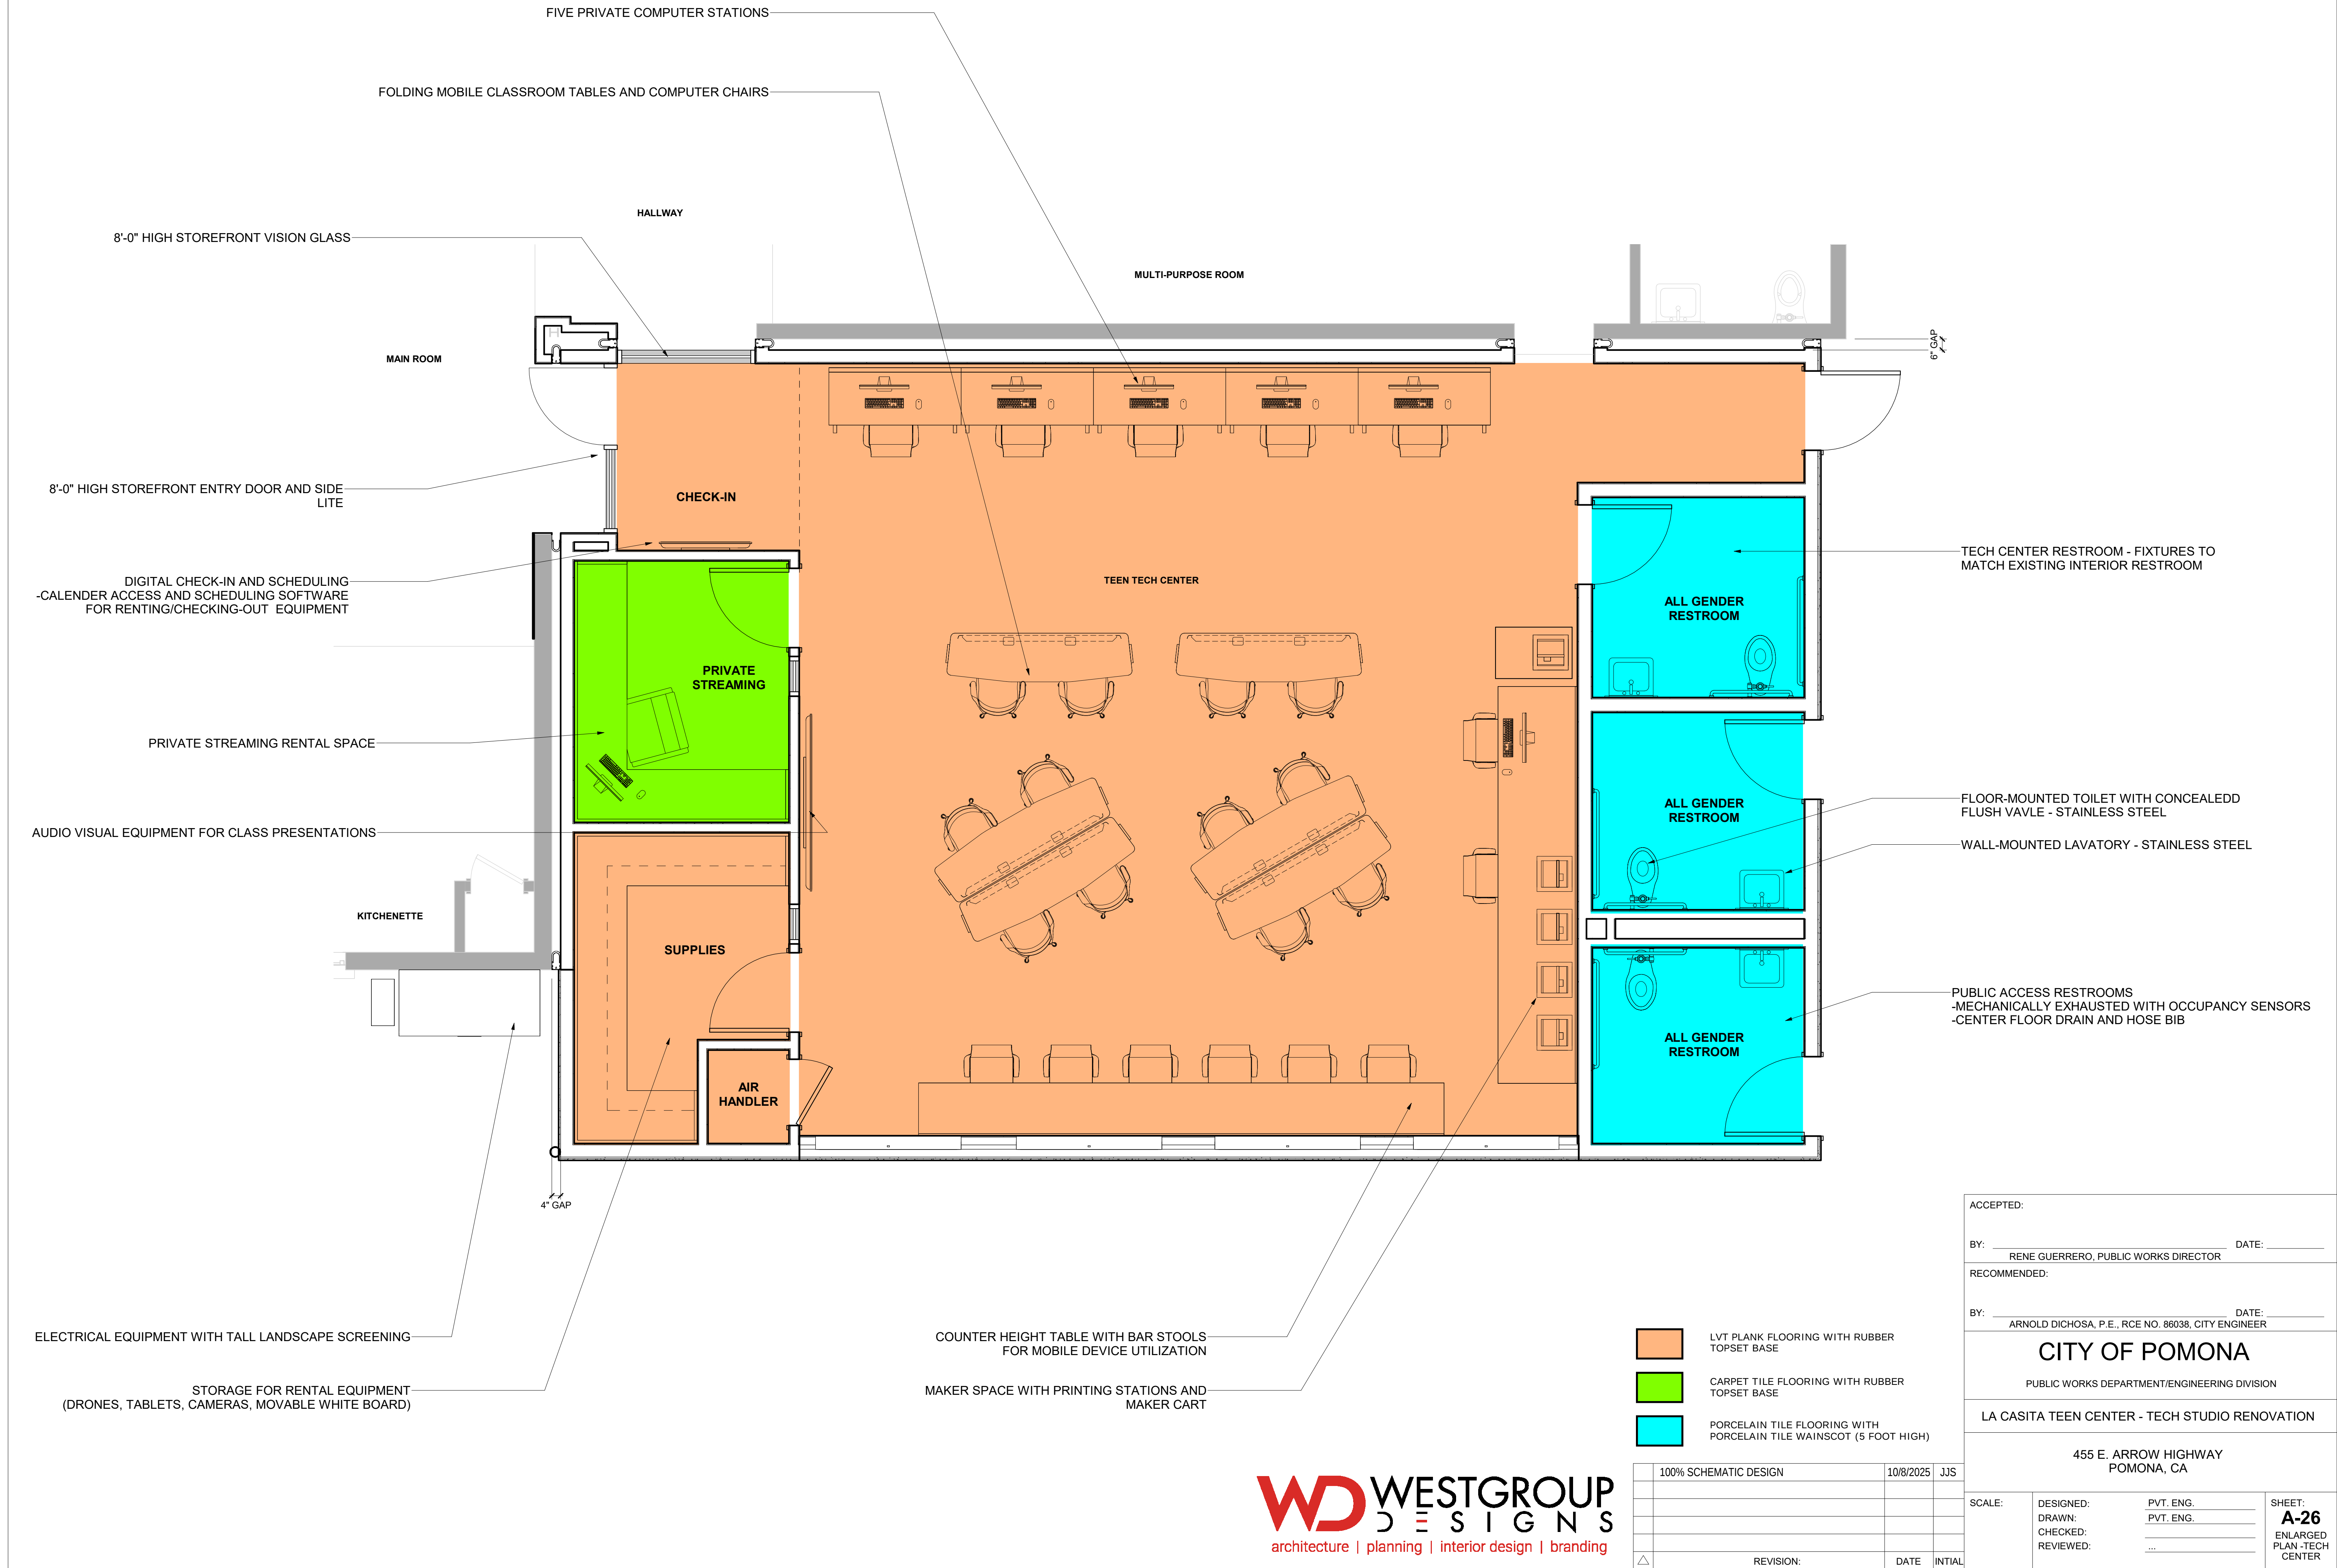

FLEXIBLE CLASSROOM FURNITURE AND FIXED COMPUTER STATIONS



PRIVATE STREAMING ROOM

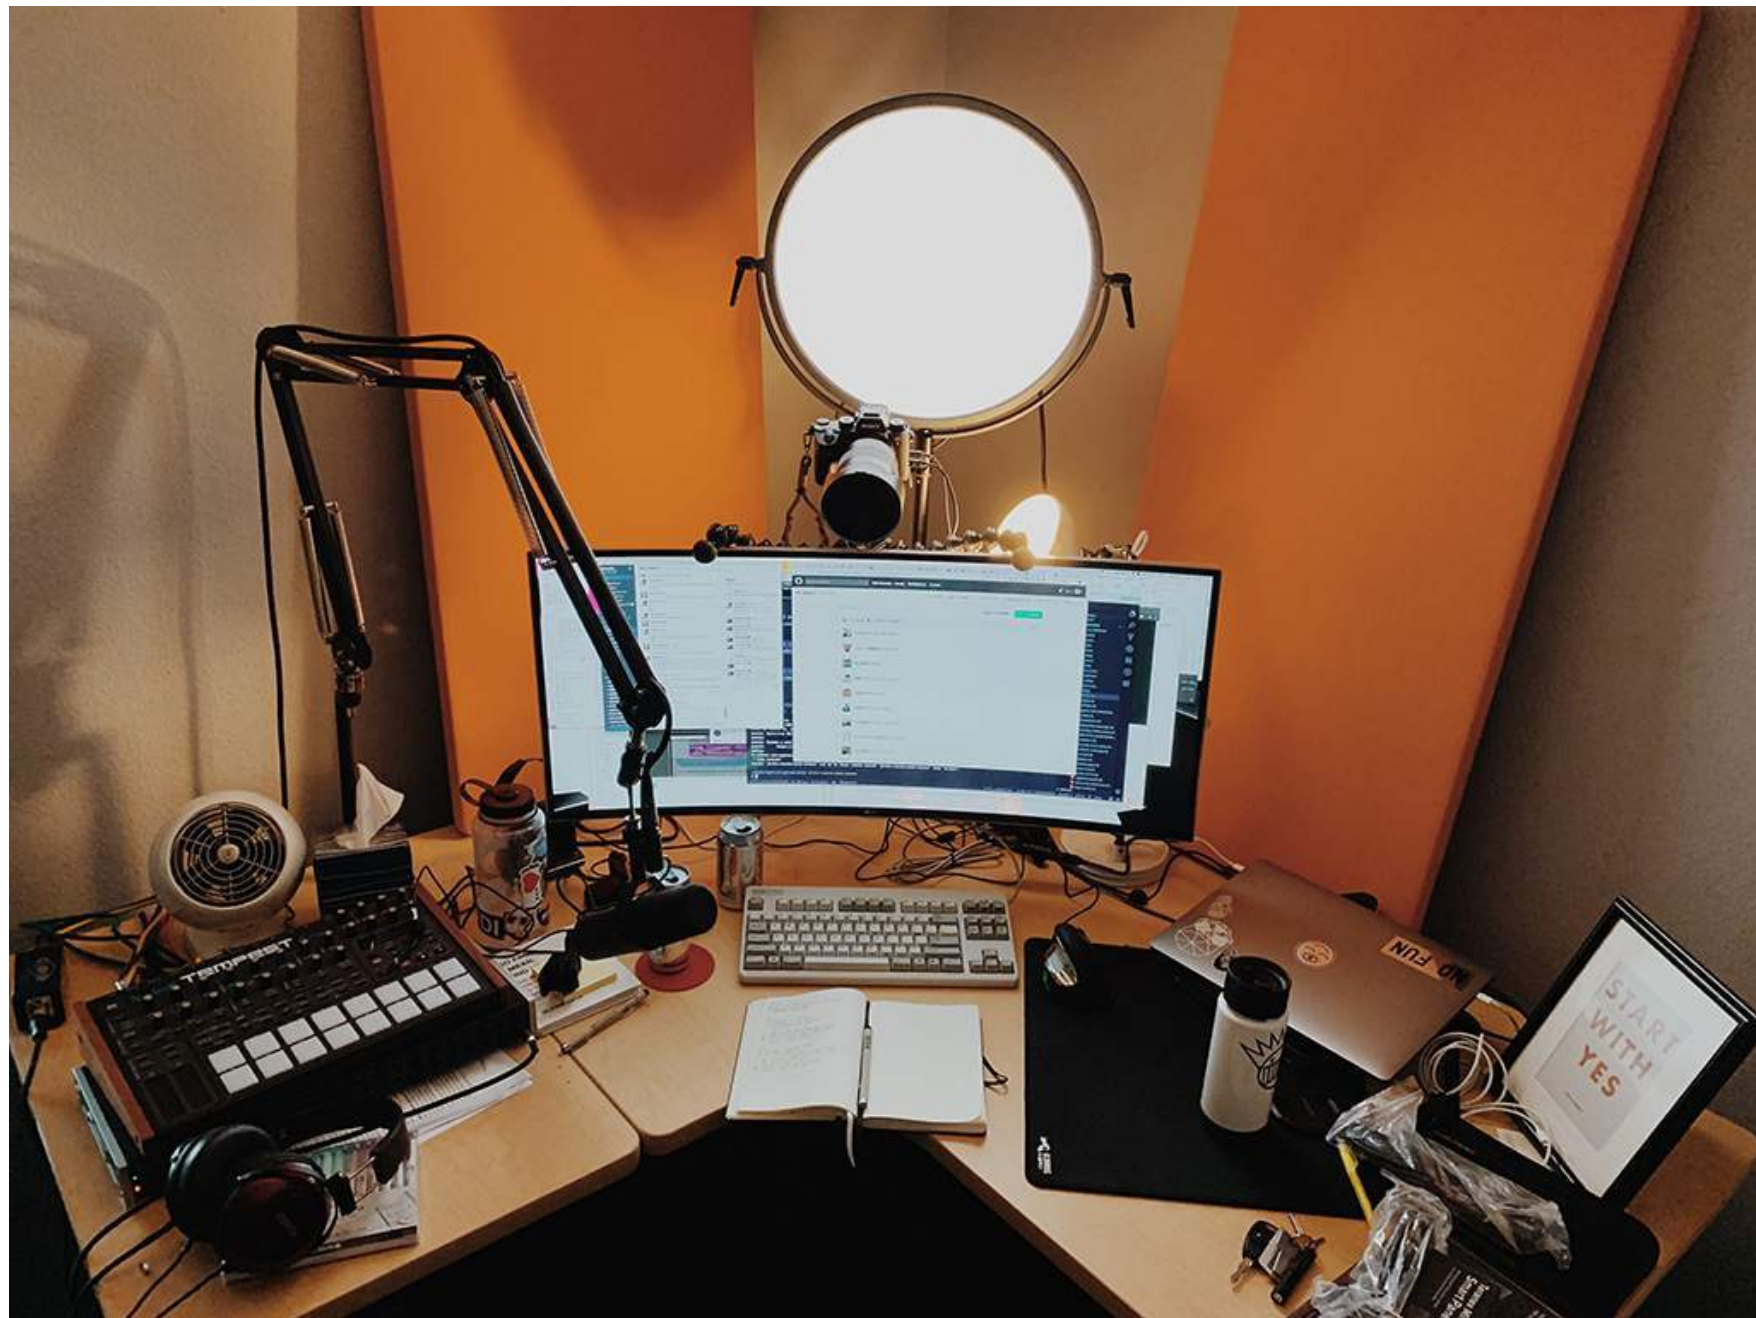

MAKERSPACE



△	REVISION:	DATE	INITIAL

ACCEPTED:			
BY: _____		DATE: _____	
RENE GUERRERO, PUBLIC WORKS DIRECTOR			
RECOMMENDED:			
BY: _____		DATE: _____	
ARNOLD DICHOSA, P.E., RCE NO. 86038, CITY ENGINEER			
CITY OF POMONA			
PUBLIC WORKS DEPARTMENT/ENGINEERING DIVISION			
LA CASITA TEEN CENTER - TECH STUDIO RENOVATION			
455 E. ARROW HIGHWAY POMONA, CA			
SCALE:	DESIGNED: DRAWN: CHECKED: REVIEWED:	PVT. ENG. PVT. ENG.	SHEET: A5-1.1 ENLARGED PLANS AND ELEVATIONS



LEGEND

BUILDING

LANDSCAPE

CONCRETE WALKING SURFACE

ASPHALT DRIVE AISLE

SCOPE OF WORK

PROPERTY LINE

100% SCHEMATIC DESIGN

10/8/2025

JJS

REVISION:

DATE

INITIAL

ACCEPTED:

BY: _____ DATE: _____

RENE GUERRERO, PUBLIC WORKS DIRECTOR

RECOMMENDED:

BY: _____ DATE: _____

ARNOLD DICHOSA, P.E., RCE NO. 86038, CITY ENGINEER

CITY OF POMONA

PUBLIC WORKS DEPARTMENT/ENGINEERING DIVISION

LA CASITA TEEN CENTER - TECH STUDIO RENOVATION

455 E. ARROW HIGHWAY
POMONA, CA

SCALE:

DESIGNED:

DRAWN:

CHECKED:

REVIEWED:

PVT. ENG.

PVT. ENG.


...

WD

WESTGROUP
DESIGNS

architecture | planning | interior design | branding

FH 624 A

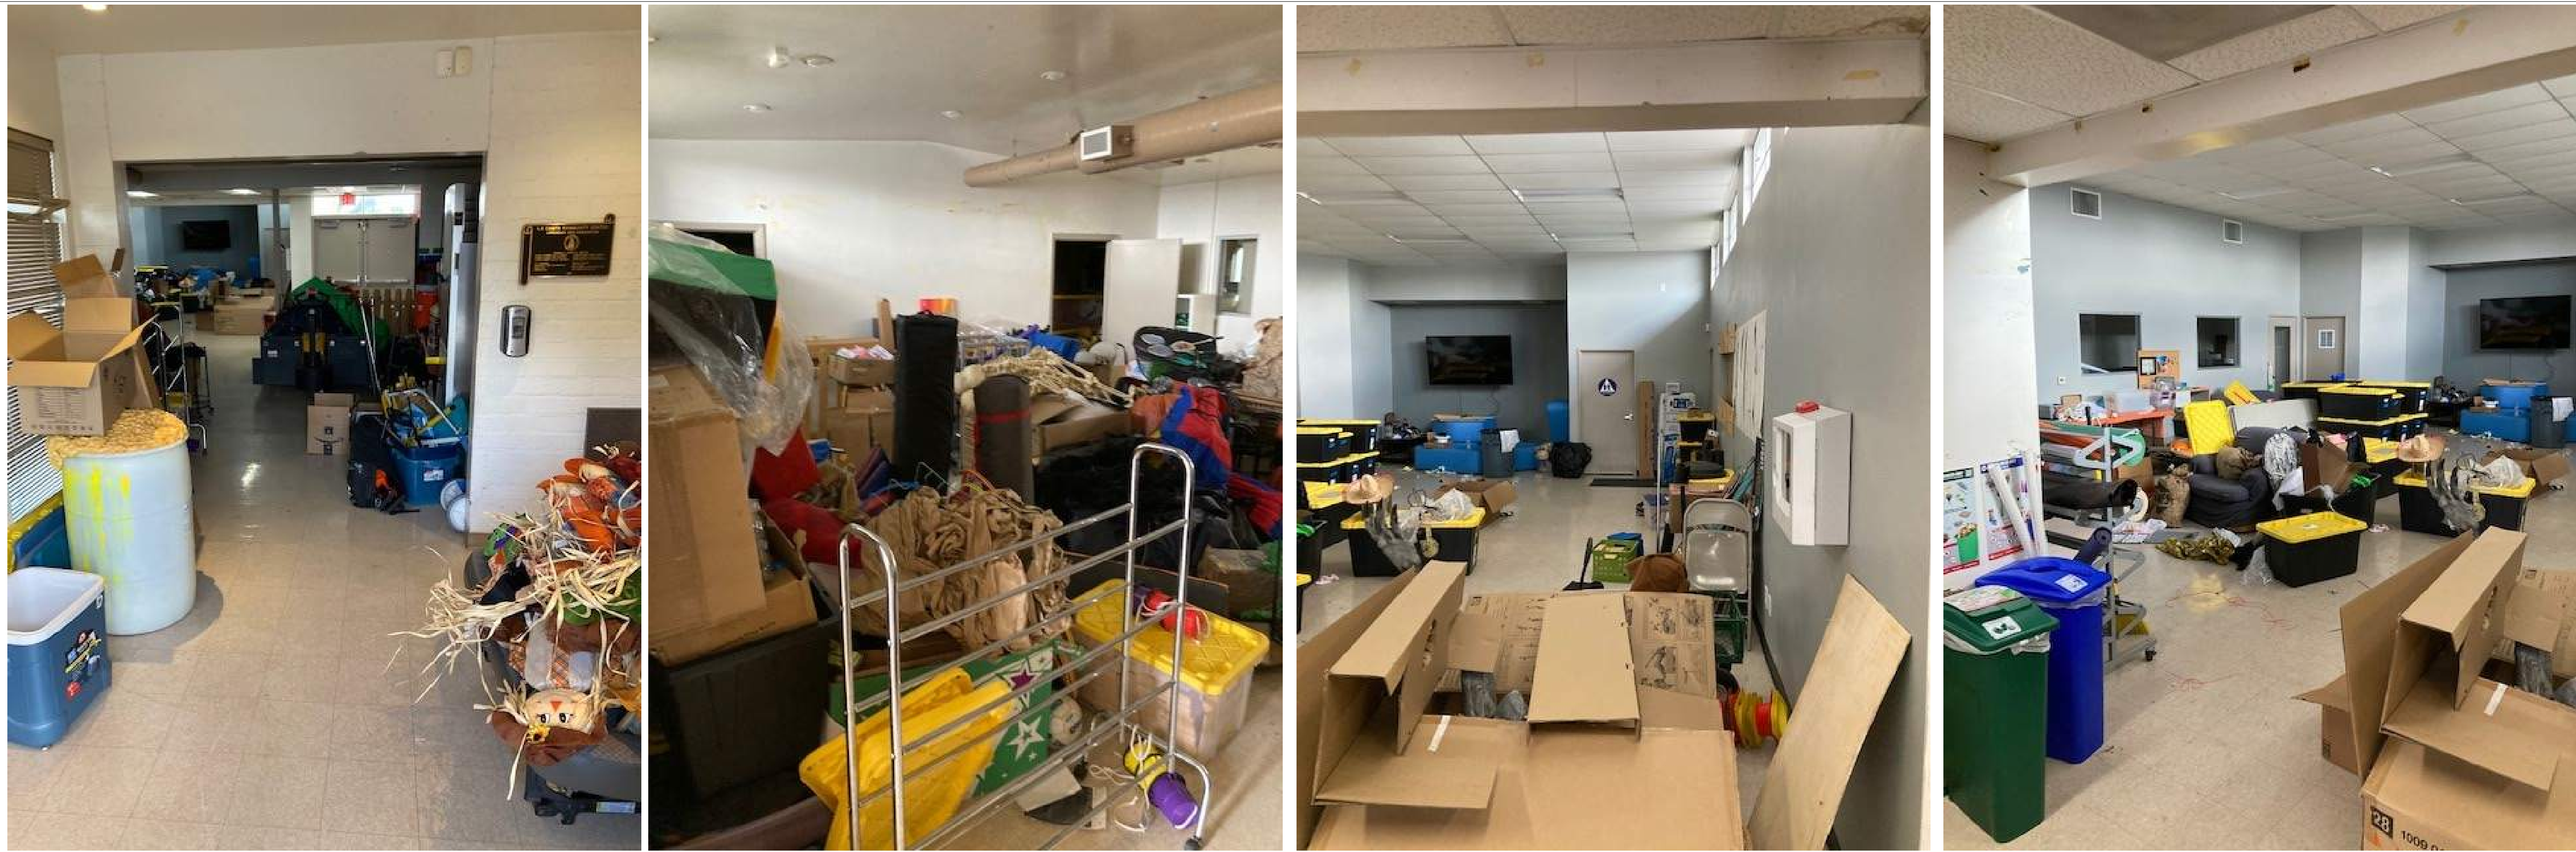

LEGEND

- BUILDING
- LANDSCAPE
- CONCRETE WALKING SURFACE
- ASPHALT DRIVE AISLE
- SCOPE OF WORK
- PROPERTY LINE

WD WESTGROUP
DESIGNS
architecture | planning | interior design | branding

100% SCHEMATIC DESIGN	10/8/2025	JJS
REVISION:	DATE	INITIAL

ACCEPTED:

BY: _____ DATE: _____
RENE GUERRERO, PUBLIC WORKS DIRECTOR

RECOMMENDED:

BY: _____ DATE: _____
ARNOLD DICHOSA, P.E., RCE NO. 86038, CITY ENGINEER

CITY OF POMONA

PUBLIC WORKS DEPARTMENT/ENGINEERING DIVISION

LA CASITA TEEN CENTER - TECH STUDIO RENOVATION

455 E. ARROW HIGHWAY
POMONA, CA

SCALE:

DESIGNED: _____
DRAWN: _____
CHECKED: _____
REVIEWED: _____

PVT. ENG. _____
PVT. ENG. _____
... _____